

E VIDEO & SOUND AND POS / PRINTERS (WALL AND CEILING MOUNTED) GROUND FLOOR PLAN

SCALE: 1/4" = 1'-0"

NOTES:
SEE SOUND SPEAKERS REQUIREMENTS NOTE AT SOUND/SPEAKERS DRAWINGS.

SECURITY SYSTEM SYMBOLS

SYMBOLS	
	CCTV
	DATA
	ELECTRICAL RECEPTACLE (normal 110V)
	ELECTRICAL RECEPTACLE DEDICATE
	CHAUVET Rogue rfi-6
	CHAUVET Intimidator spot 360

SPEAKER SYSTEM SYMBOLS

TYPE OF SPEAKER	MODEL	COVERAGE
	QSC K1A-12	90°
	QSC KS-212C	180°
	QSC KS-112	360°
	QSC E-112	80°
	QSC CP-8	90°
	QSC AD-P-SUB	360°
	QSC AD-P-SAT	360°

VIDEO SYSTEM SYMBOLS

	TENSIONED CURTAIN ELITE SCREEN TE 155 HW2
	PROJECTOR LASER OPTIMA 2H 400ST
	TV LG 50"
	J-BOX FOR RGB VIDEO SYSTEM
	RECEPTACLE 110v

CABLE & DATA OUTLET (4"X4" 2 1/2" OUTLET BOX) FOR HEIGHT MOUNTED REFER TO SOUND TECHNIC DRAWINGS.

VIDEO SYSTEM SYMBOLS

	TENSIONED CURTAIN ELITE SCREEN TE 155 HW2
	PROJECTOR LASER OPTIMA 2H 400ST
	TV LG 50"
	J-BOX FOR RGB VIDEO SYSTEM
	RECEPTACLE 110v



OWNER:
LINCOLN DREXEL LTD.
ANDY CARROLL DREXEL BL.
1655 ALTON ROAD #403
MIAMI BEACH, FL 33140

ARCHITECT:
FORM GROUP, INC.
4300 SW 73 AVE. #108
MIAMI, FL 33155
PH: 305-443-4244

INTERIOR DESIGNER:

KITCHEN CONSULTANT:
LACE FOOD SERVICE
10400 NW 26TH STREET,
MIAMI, FL 33172
PH: 305-613-5223

MEP ENGINEER:
LAUREDO ENGINEERING
COMPANY
1000 N. MIAMI AVE. #100
MIAMI, FL 33136
TEL: 305-375-1111
FAX: 305-375-1112
E-MAIL: info@laredo.com

STRUCTURAL ENGINEER:

INTERIOR TENANT BUILT-OUT FOR:

**ANDRÉS
CARNE DE RES**

LINCOLN DREXEL BUILDING
1655 DREXEL AVENUE
MIAMI BEACH, FL 33139

REVISIONS:
1. 09/30/21 B.D.C



FORM GROUP, INC.
4300 SW 73 AVE. SUITE 108, MIAMI, FL 33155
TEL: 305-443-4244 FAX: 305-443-4245
ARCHITECT OF RECORD

PROJECT NO. 15-1037
DATE: 3-8-20
SHEET: AS SHOWN
TITLE: VIDEO & SOUND GROUND FLOOR PLAN
DRAWING NO.: E-101.2



ARCHITECT:
FORM GROUP, INC.
4300 SW 73 AVE., #106
MIAMI, FL, 33155

PH: 305-443-4244

INTERIOR DESIGNER

KEECHEN COMBIA XANG

LACE FOOD SERVICE
18100 N. ALBERTA STREET

10450 NW 26TH STREET
MIRAMAR, FL, 33172

PH: 305-513-5223

MEP ENGINEER:

LAUREDO ENGINEERING
COMPANY
MECHANICAL & ELECTRICAL ENGINEERS
STATE OF FLORIDA
2029 NE 189th Street
Fort Lauderdale, FL 33310
TEL: 305-557-2264
FAX: 305-557-2264

STRUCTURAL ENGINEER

INTERIOR TENANT BUILT-OUT FOR:

ANDRÉS
CARNE DE RES

LINCOLN DREXEL BUILDING
1655 DREXEL AVENUE
MIAMI BEACH, FL 33139

REVISIONS:

1	09/30/21	B.D.C
---	----------	-------

FORMGROUP
architecture . planning

FORM GROUP, INC.

FORM GROUP, INC.
4500 EMU TS BLVD, ELSTON, OH, 44022-0101
TEL. 305-463-4244 FX. 305-463-3338
ARCHITECT OF RECORD: OMAR MORALI
68-0014601

© 1995 PERKINS, TECHNOLOGIE AND DESIGN AND THE PROPERTY OF IT
NO PART THEREOF MAY BE COPIED, REPRODUCED OR TRANSMITTED

REFUGY FOR BROTHERS: CONCEPT OF THE ARCHITECT

PROJECT NO.	TITLE:
-------------	--------

19-1007 VIDEO & SOUND

DATE: 3.9.79 MEZZANINE FLOOR PL


3-5-20

SCALE: DRAWING NO:

AS SHOWN


F-102

L 102.

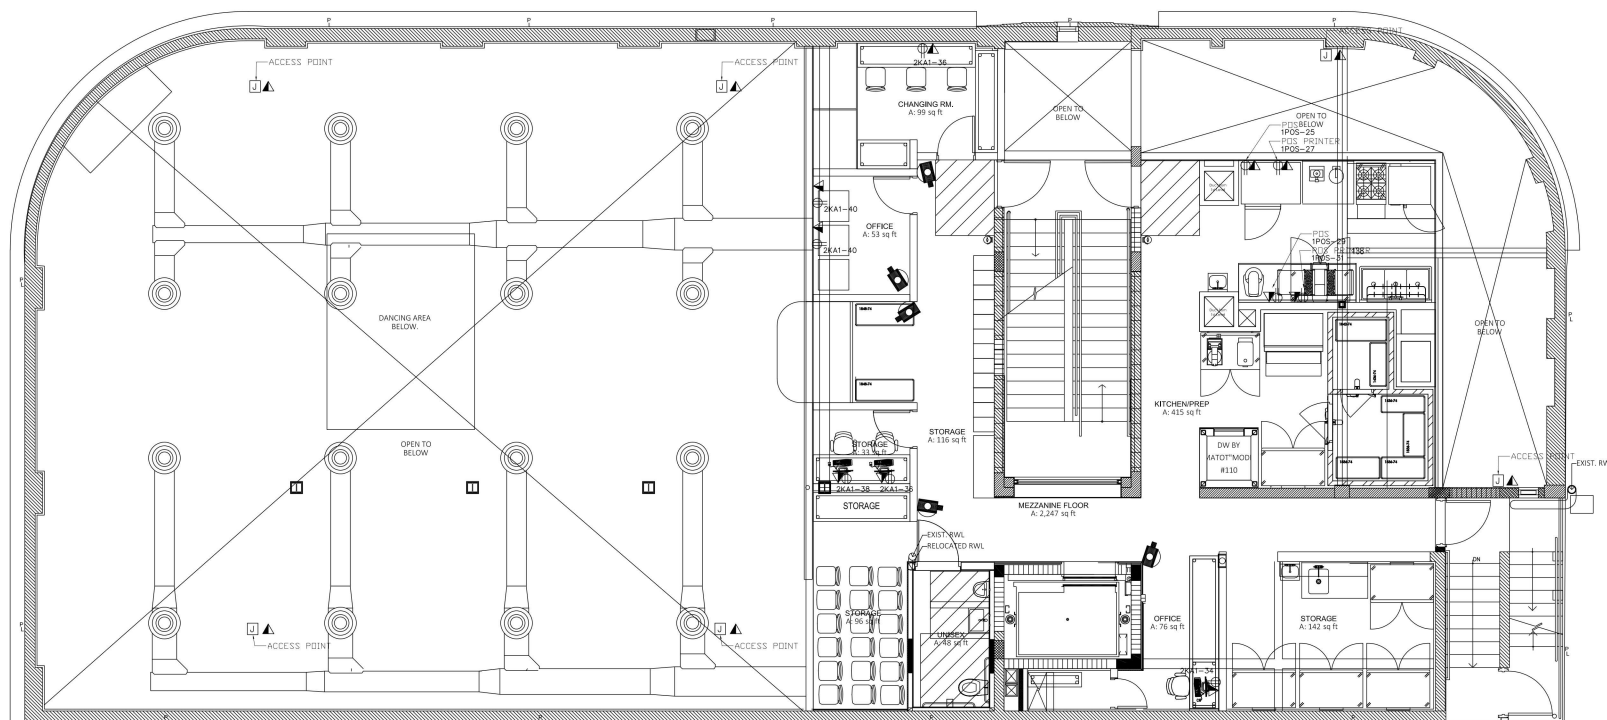



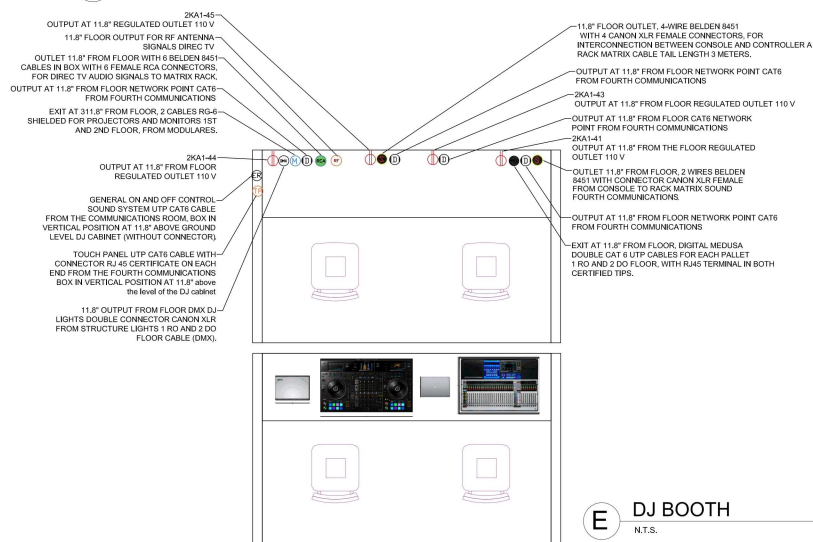


VIDEO & SOUND AND POS / PRINTERS (WALL AND CEILING MOUNTED) MEZZANINE FLOOR PLAN

E VIDEO &
SCALE: 1/4" = 1'-0"









E DJ BOOTH
N.T.S.

VIDEO SYSTEM SYMBOLS









 






	TENSIONED CURTAIN ELITE SCREEN TE 135 HW2
	PROJECTOR LASER OPTOMA ZH 406ST
	TV LG 55"
	J-BOX FOR RG6 VIDEO SYSTEM
	RECEPTACLE 110v


SECURITY SYSTEM SYMBOLS

SYMBOLS	
	CCTV
	DATA
	ELECTRICAL RECEPTACLE (normal 110V)
	ELECTRICAL RECEPTACLE DEDICATE

	CHAUVET Rogue rtle-b
	CHAUVET intimidator spot 360

SPEAKER SYSTEM SYMBOLS

TYPE OF SPEAKER	MODEL	COVERAGE
 ACTIVE Line Array	QSC XLA-12	 180°
 ACTIVE Cardioid Subwoofer	QSC KS-120C	 180°
 ACTIVE Subwoofer	QSC KS-12	 360°
 PASSIVE Full Range	QSC E-12	 85°
 ACTIVE Full Range	QSC CP-4	 90°
 PASSIVE Subwoofer	QSC AD-P-SUB	 360°
 PASSIVE Pendant Full Range	QSC AD-P-SAT	 360°
 CABLE & DATA OUTLET (v. v.2 12 OUTLET BOX) FOR HEIGHT MOUNTED REFER TO SOUND TECH DRAWINGS.		

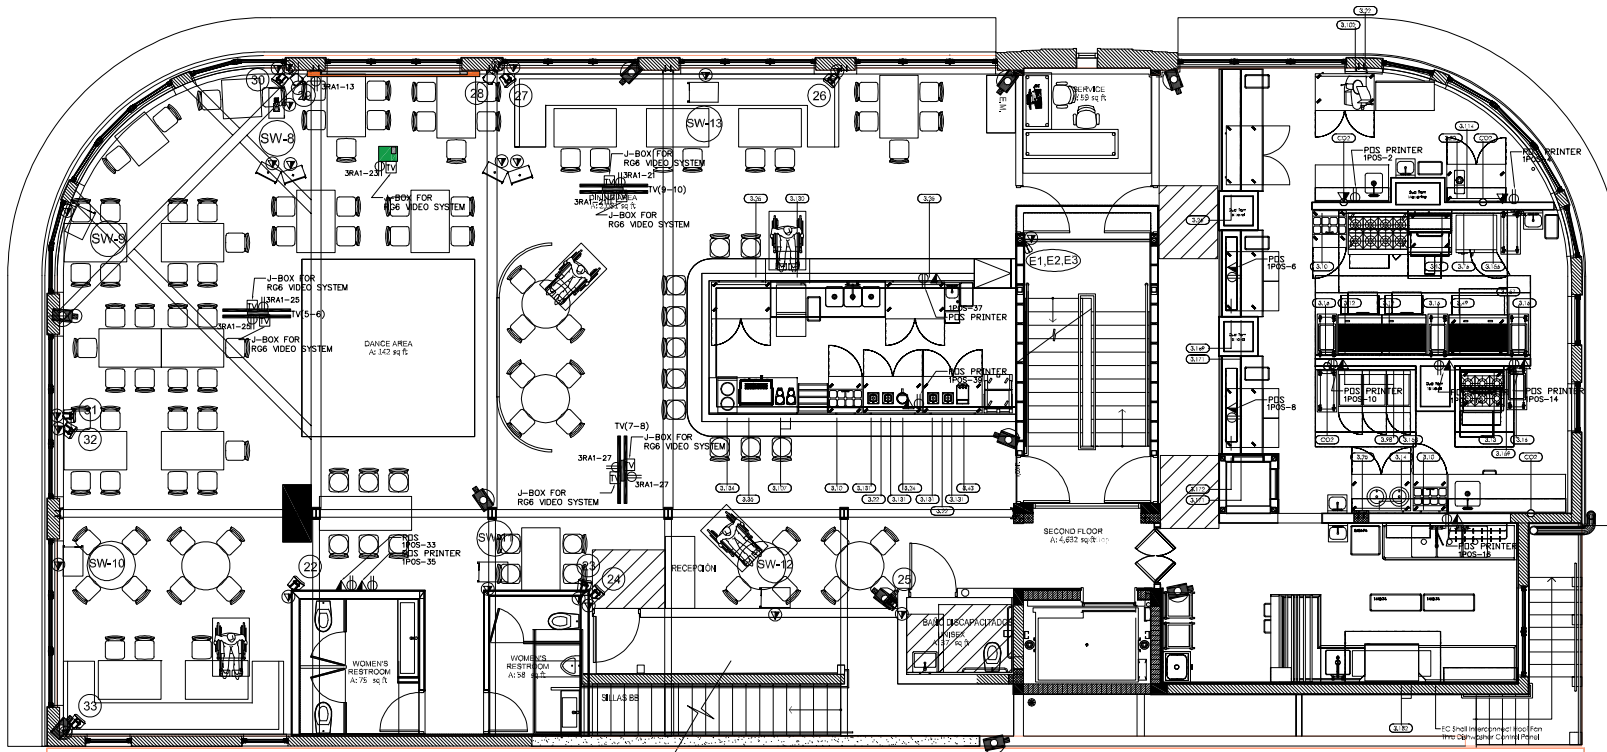

NOTE:
SEE SOUND SPEAKERS REQUIREMENTS NOTE AT SOUND/SPEAKERS DRAWINGS.

E VIDEO & SOUND AND POS / PRINTERS (WALL AND CEILING MOUNTED) POWER SECOND FLOOR PLAN
SCALE: 1/4" = 1'-0"

VIDEO SYSTEM SYMBOLS

	TENBYONES CURTAIN ELITE SCREEN TE 135 1112
	PROJECTOR LASER OPTOMA 2H 4088T
	J-BOX FOR R66 VIDEO SYSTEM
	RECEPTACLE 110V

SECURITY SYSTEM SYMBOLS

SYMBOLS	
	CCTV
	DATA
	ELECTRICAL RECEPTACLE (normal 110V)
	ELECTRICAL RECEPTACLE DEDICATED
	CHAUXET ROPE R-2
	CHAUXET INITIATOR spot 385

SPEAKER SYSTEM SYMBOLS

TYPE OF SPEAKER	MODEL	COVERAGE
	QSC KL-A-12	90°
	QSC KS-212C	180°
	QSC KS-12	360°
	QSC E-112	90°
	QSC CP-8	90°
	QSC AD-P-36B	360°
	QSC AD-P-36AT	360°
	CABLE & DATA OUTLET (1/4" x 1/2" x 1/2" OUTLET BOX) FOR HEIGHT ADJUSTED REFER TO SOUND DRAWINGS.	



OWNER:
LINCOLN DREXEL, LTD.
AND LINCOLN DREXEL II,
3851 ALTON ROAD #400
MIAMI BEACH, FL 33140

ARCHITECTS:
FORM GROUP INC.
4305 SW 73 AVE. #108
MIAMI, FL 33155
PH: 305-443-4244

INTERIOR DESIGNER:

INTERIOR CONSULTANT:
LACE FOOD SERVICE
1540 NW 20TH STREET,
MIAMI, FL 33172
PH: 305-613-6223

MEP ENGINEER:
LAUREDO ENGINEERING
COMPANY
2000 N.W. 10TH AVE.
SUITE 200
MIAMI, FL 33136
PH: 305-581-1111

STRUCTURAL ENGINEER:

INTERIOR TENANT BUILT-OUT FOR:

**ANDRÉS
CARNE DE RES**

LINCOLN DREXEL BUILDING
1650 DREXEL AVENUE
MIAMI BEACH, FL 33139

DATE: 09/30/21 BY: B.D.C.



FORMGROUP
architecture . planning

FORM GROUP, INC.
4305 SW 73 AVE. SUITE 108, MIAMI, FL 33155
TEL: 305-443-4244 FAX: 305-443-4245
ARCHITECT OF RECORD

PROJECT NO.: 19-1007
DATE: 5-8-20
SCALE: AS SHOWN
TITLE: VIDEO & SOUND / SECOND FLOOR PLAN
DRAWING NO.: E-103.2

