


PLUMBING FIXTURE SITE LEGEND

D1- DRAIN MULTI LEVEL PLANTER 4" (SEE LANDSCAPE PLANS FOR DETAILS)
D2- DRAIN SQUARE STRUCTURE 6"
D3- DRAIN COMBINATION
D4- TERRACE FLOOR DRAIN
D5- DRAIN TRENCH

SCE- EXISTING SCUPPER
SCF- PROPOSED SCUPPER
D14- TERRACE DECK DRAIN
D17- ROUND ROOF DRAIN

PLUMBING LEGEND
1/8" = 1'-0"

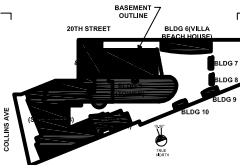

Rev.		Date
1	REVISION 1	11/30/2023
2	REVISION 2	02/21/2024
3	REVISION 3	05/03/2024

2104

Shore Club
1901 Collins Ave.
Miami Beach, FL 33139

Owner:
Name: Shore Club Property Owner LLC
Address: 4400 Biscayne Blvd, Suite 900
Miami, FL 33137
Name: Adam Collins
Email: gcollins@shoreclub.com

Design Architect:
Name: Robert A.M. Stern Architects LLP
Address: One Park Avenue
New York, NY 10016
Tel: 212.667.5100
Email: G.Stern@rsam.com

Architect:
Name: Kohl Korp
Address: 671 NW 8th Street
Miami, FL 33127
Tel: 305.571.0010
Email: kohlcorp@kohlcorp.com

MEP:
Name: Conestall
Address: 488 Seventh Avenue
New York, NY 10018
Tel: 212.615.3811
Email: cullen@conestall.com

Structural:
Name: DeBrienne Consulting Engineers
Address: 800 E 9th Avenue, 8th Floor
Miami, FL 33131
Tel: 305.441.0700
Email: adriana.debrienne@debrienne.com

Landscape Architect:
Name: Island Planning Corporation
Address: 248 Washington Ave
Miami Beach, FL 33139
Tel: 305.534.5725
Email: info@islandplanningcorporation.com

Civil:
Name: Kinley-Horn
Address: 2 Alhambra Plaza
Suite 800, Coral Gables, FL 33134
Tel: 305-875-0205

Interior Architect:
Name: SLCE Architects, LLP
Address: 1308 Broadway
New York, NY 10018
Tel: 212.679.6400

Interior Design: See adjacent set
Name: Bryan O'Sullivan Studio
Address: 180 Vester Street
Suite 100 New York, NY 10014
Tel: +1 347 778 9979

Life Safety:
Name: SLB
Address: 283 Palmetto Ave.
Coral Gables, FL 33134
Tel: +1 888 224 9811

IT Consultant:
Name: Deployed Technologies
Address: 14160 Chapparral Lane
Bryan, TX 77802
Tel: +1 817 802 1800
Email: john@deployedtechnologies.com


Historic Preservation:
Name: Heritage Architectural Associates
Address: 4350 Biscayne Blvd, Suite 201
Miami, FL 33137
Tel: +1 305 761 3842
Email: savitaran@heritagearchitectural.com



LOADING ENLARGED 1-2

Date:	05/13/2024	Sheet No.
Scale:	1/8" = 1'-0"	A-3.2.01
Project:	2104	

MILESTONE 6 - PROGRESS CD SET - 06/13/2024

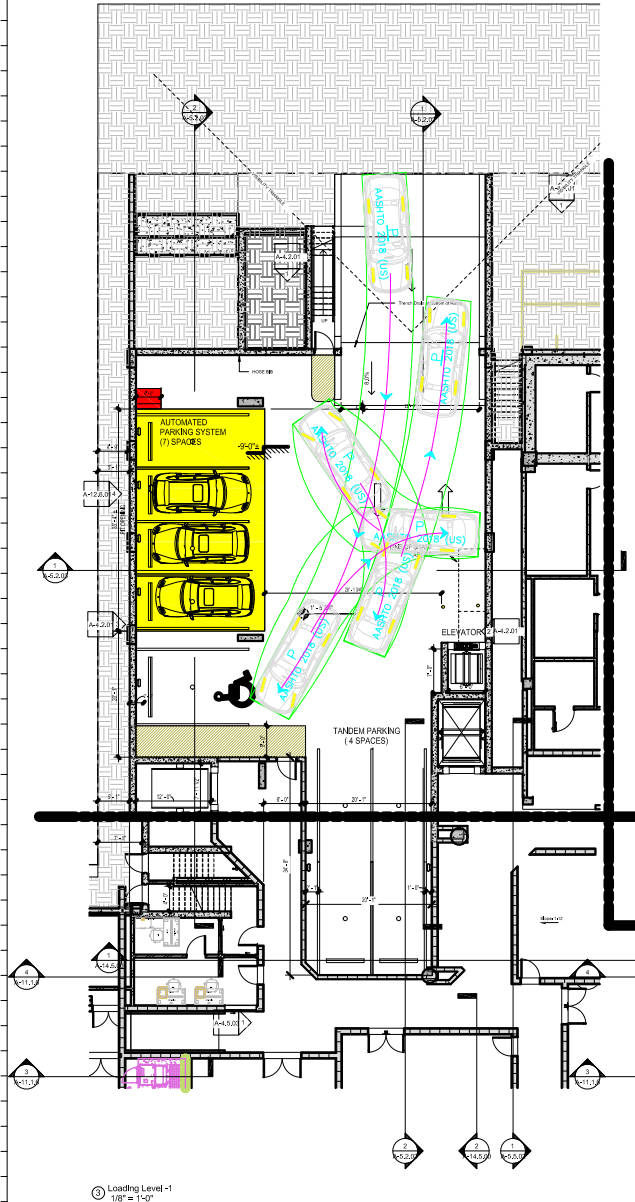

Loading Level-1
1/8" = 1'-0"